


eyang Mar 28, 2018 10:25am C:\Users\eyang\Project\Wise\CEMOP\CADD\CWVC1001.dwg

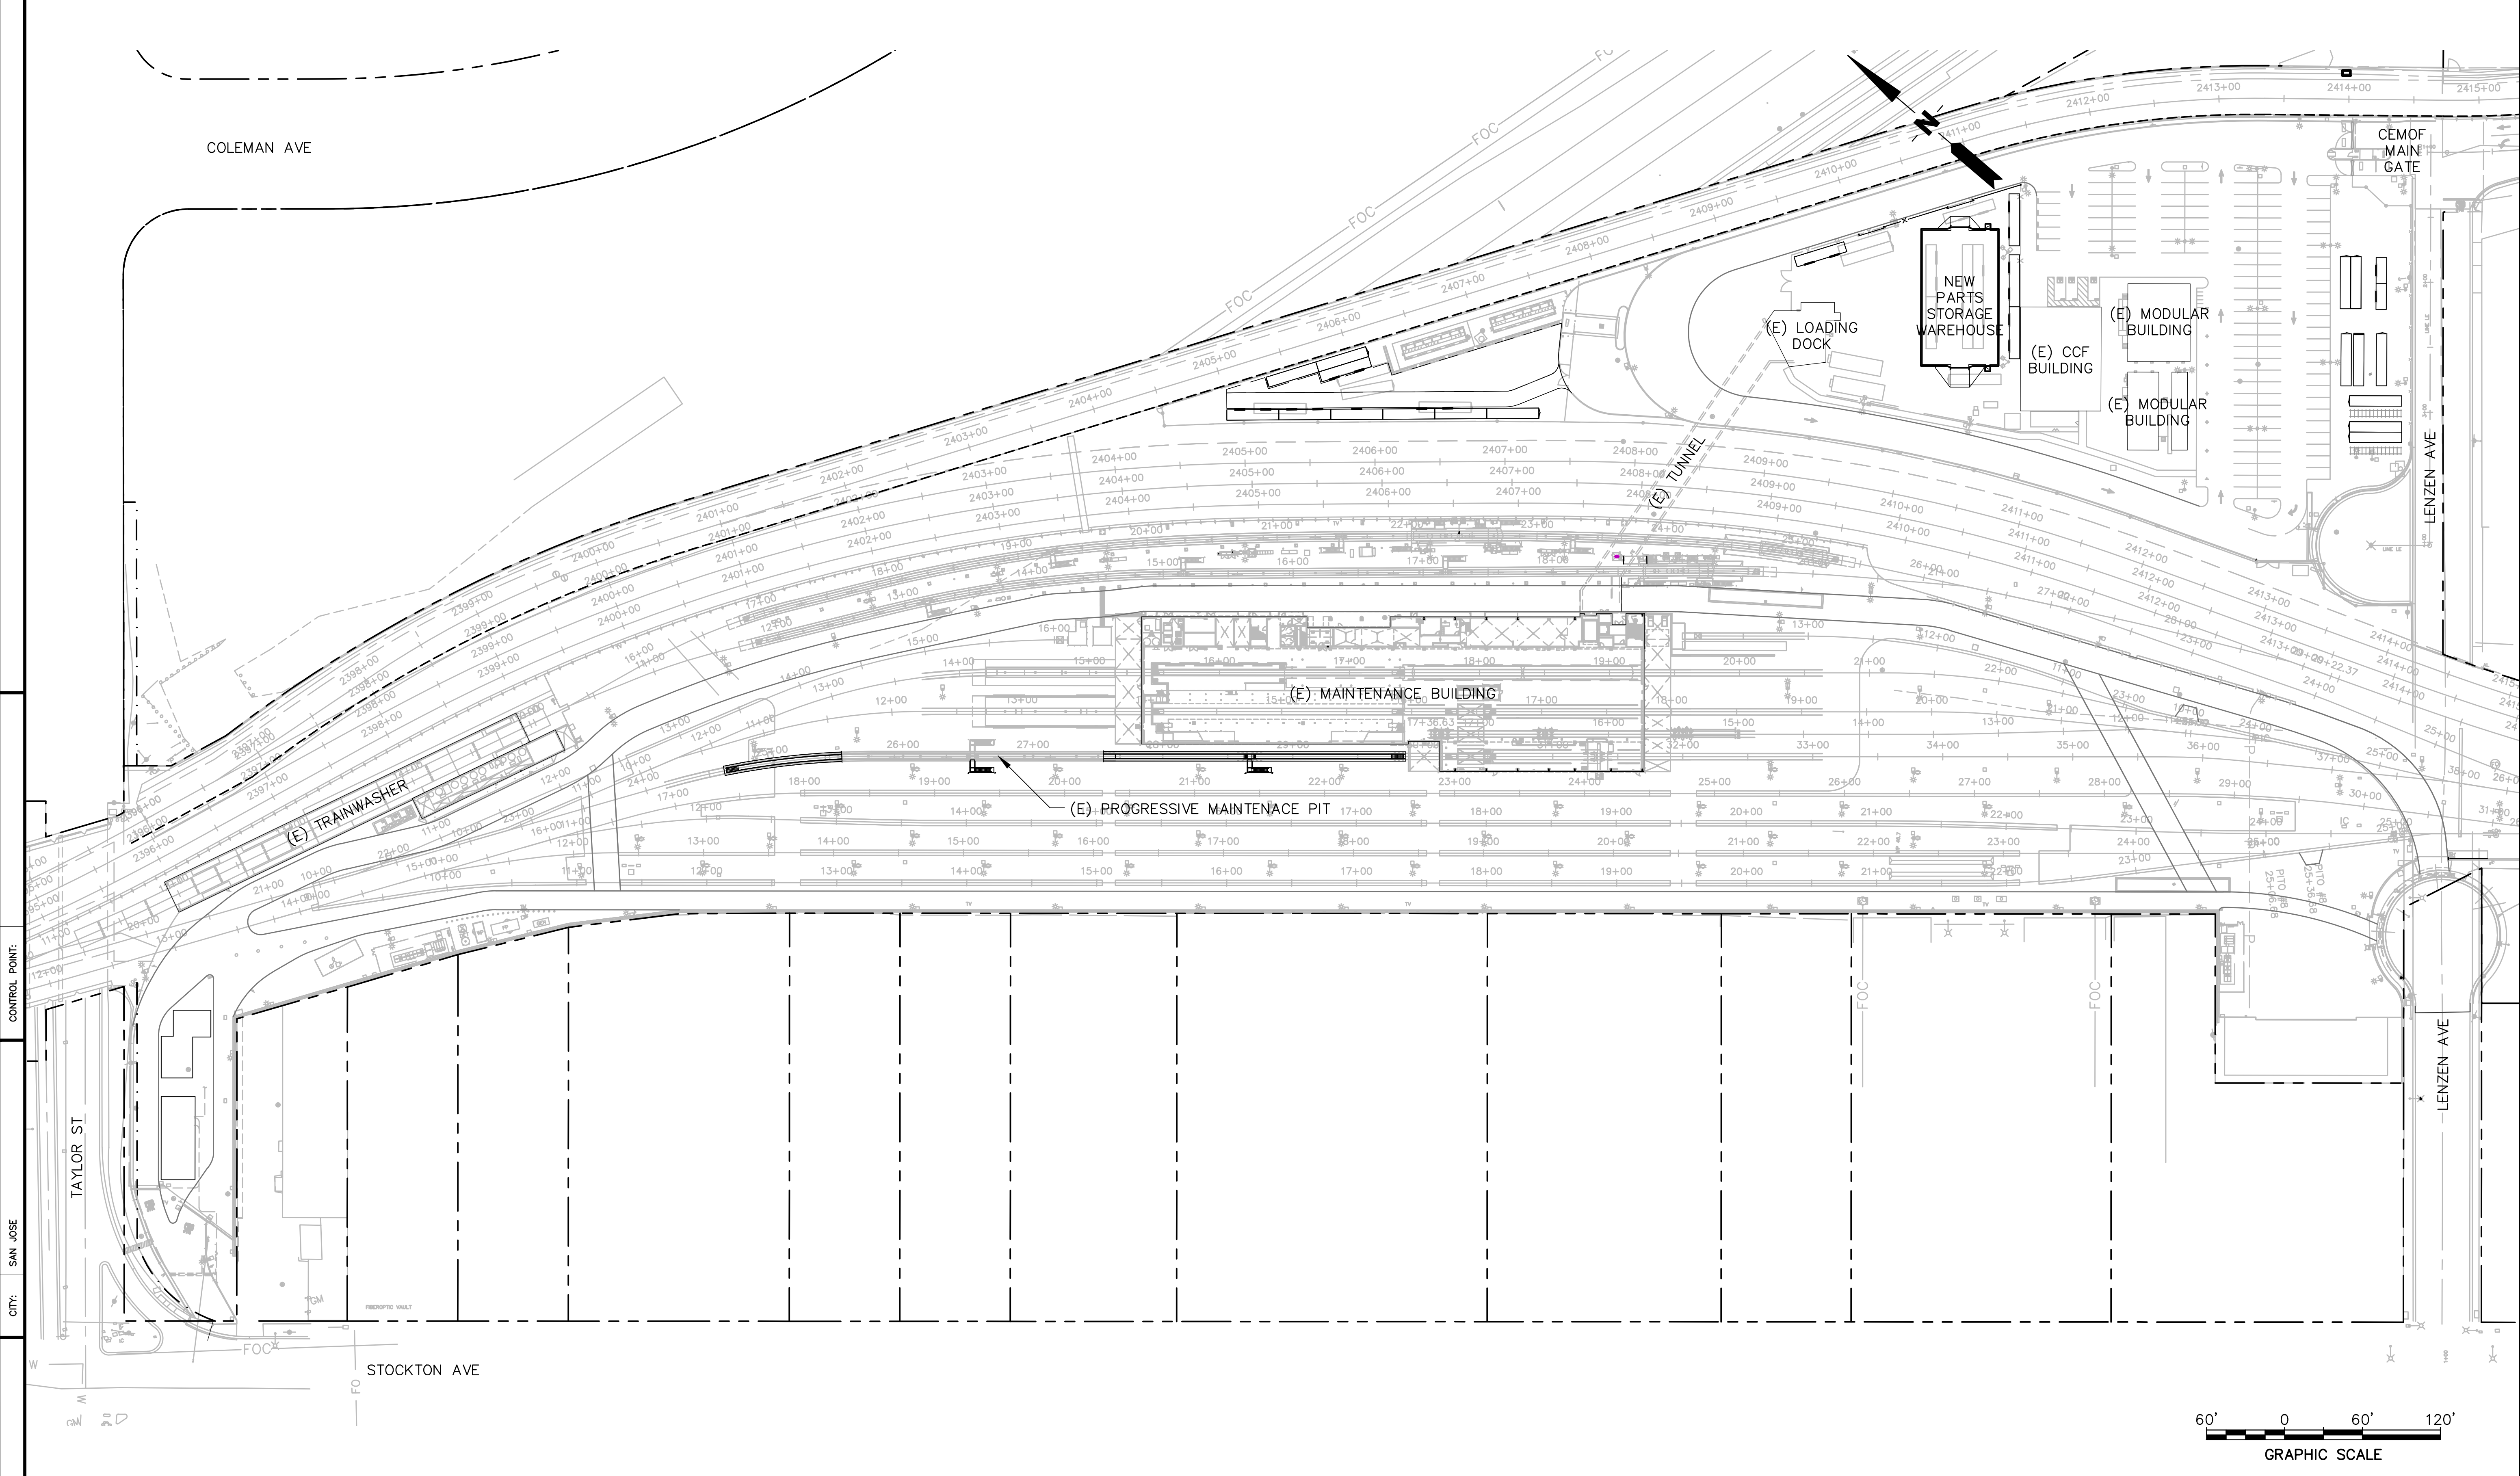

REV	DATE	BY	SUB	APP	DESCRIPTION	REV	DATE	BY	SUB	APP	DESCRIPTION
0	033018				ISSUED FOR BID						

DESIGNED
E. YANG
DRAWN
E. YANG
CHECKED
G. THIEBAUT
IN CHARGE
G. THIEBAUT
DATE
03302018



HNTB
HNTB Corporation
Engineers Architects Planners
G. Thiebaut
APPROVED



DEPUTY DIRECTOR
PROJECT MANAGEMENT
STRUCTURES
TRACK/CIVIL

PENINSULA CORRIDOR JOINT POWERS BOARD		CADD FILE NAME CMVC1001	CADD DATE 03302018
CALMOD - CEMOF FACILITY		SCALE 1"=60'	MILEPOST 45.7 - 46.6
OVERALL SITE PLAN		CONTRACT NO 18-J-C071	REV 0
		DWG NO C1001	PAGE NO 5